


Community Revitalization
Programme CRP







International Organization
for Migration - IRAQ



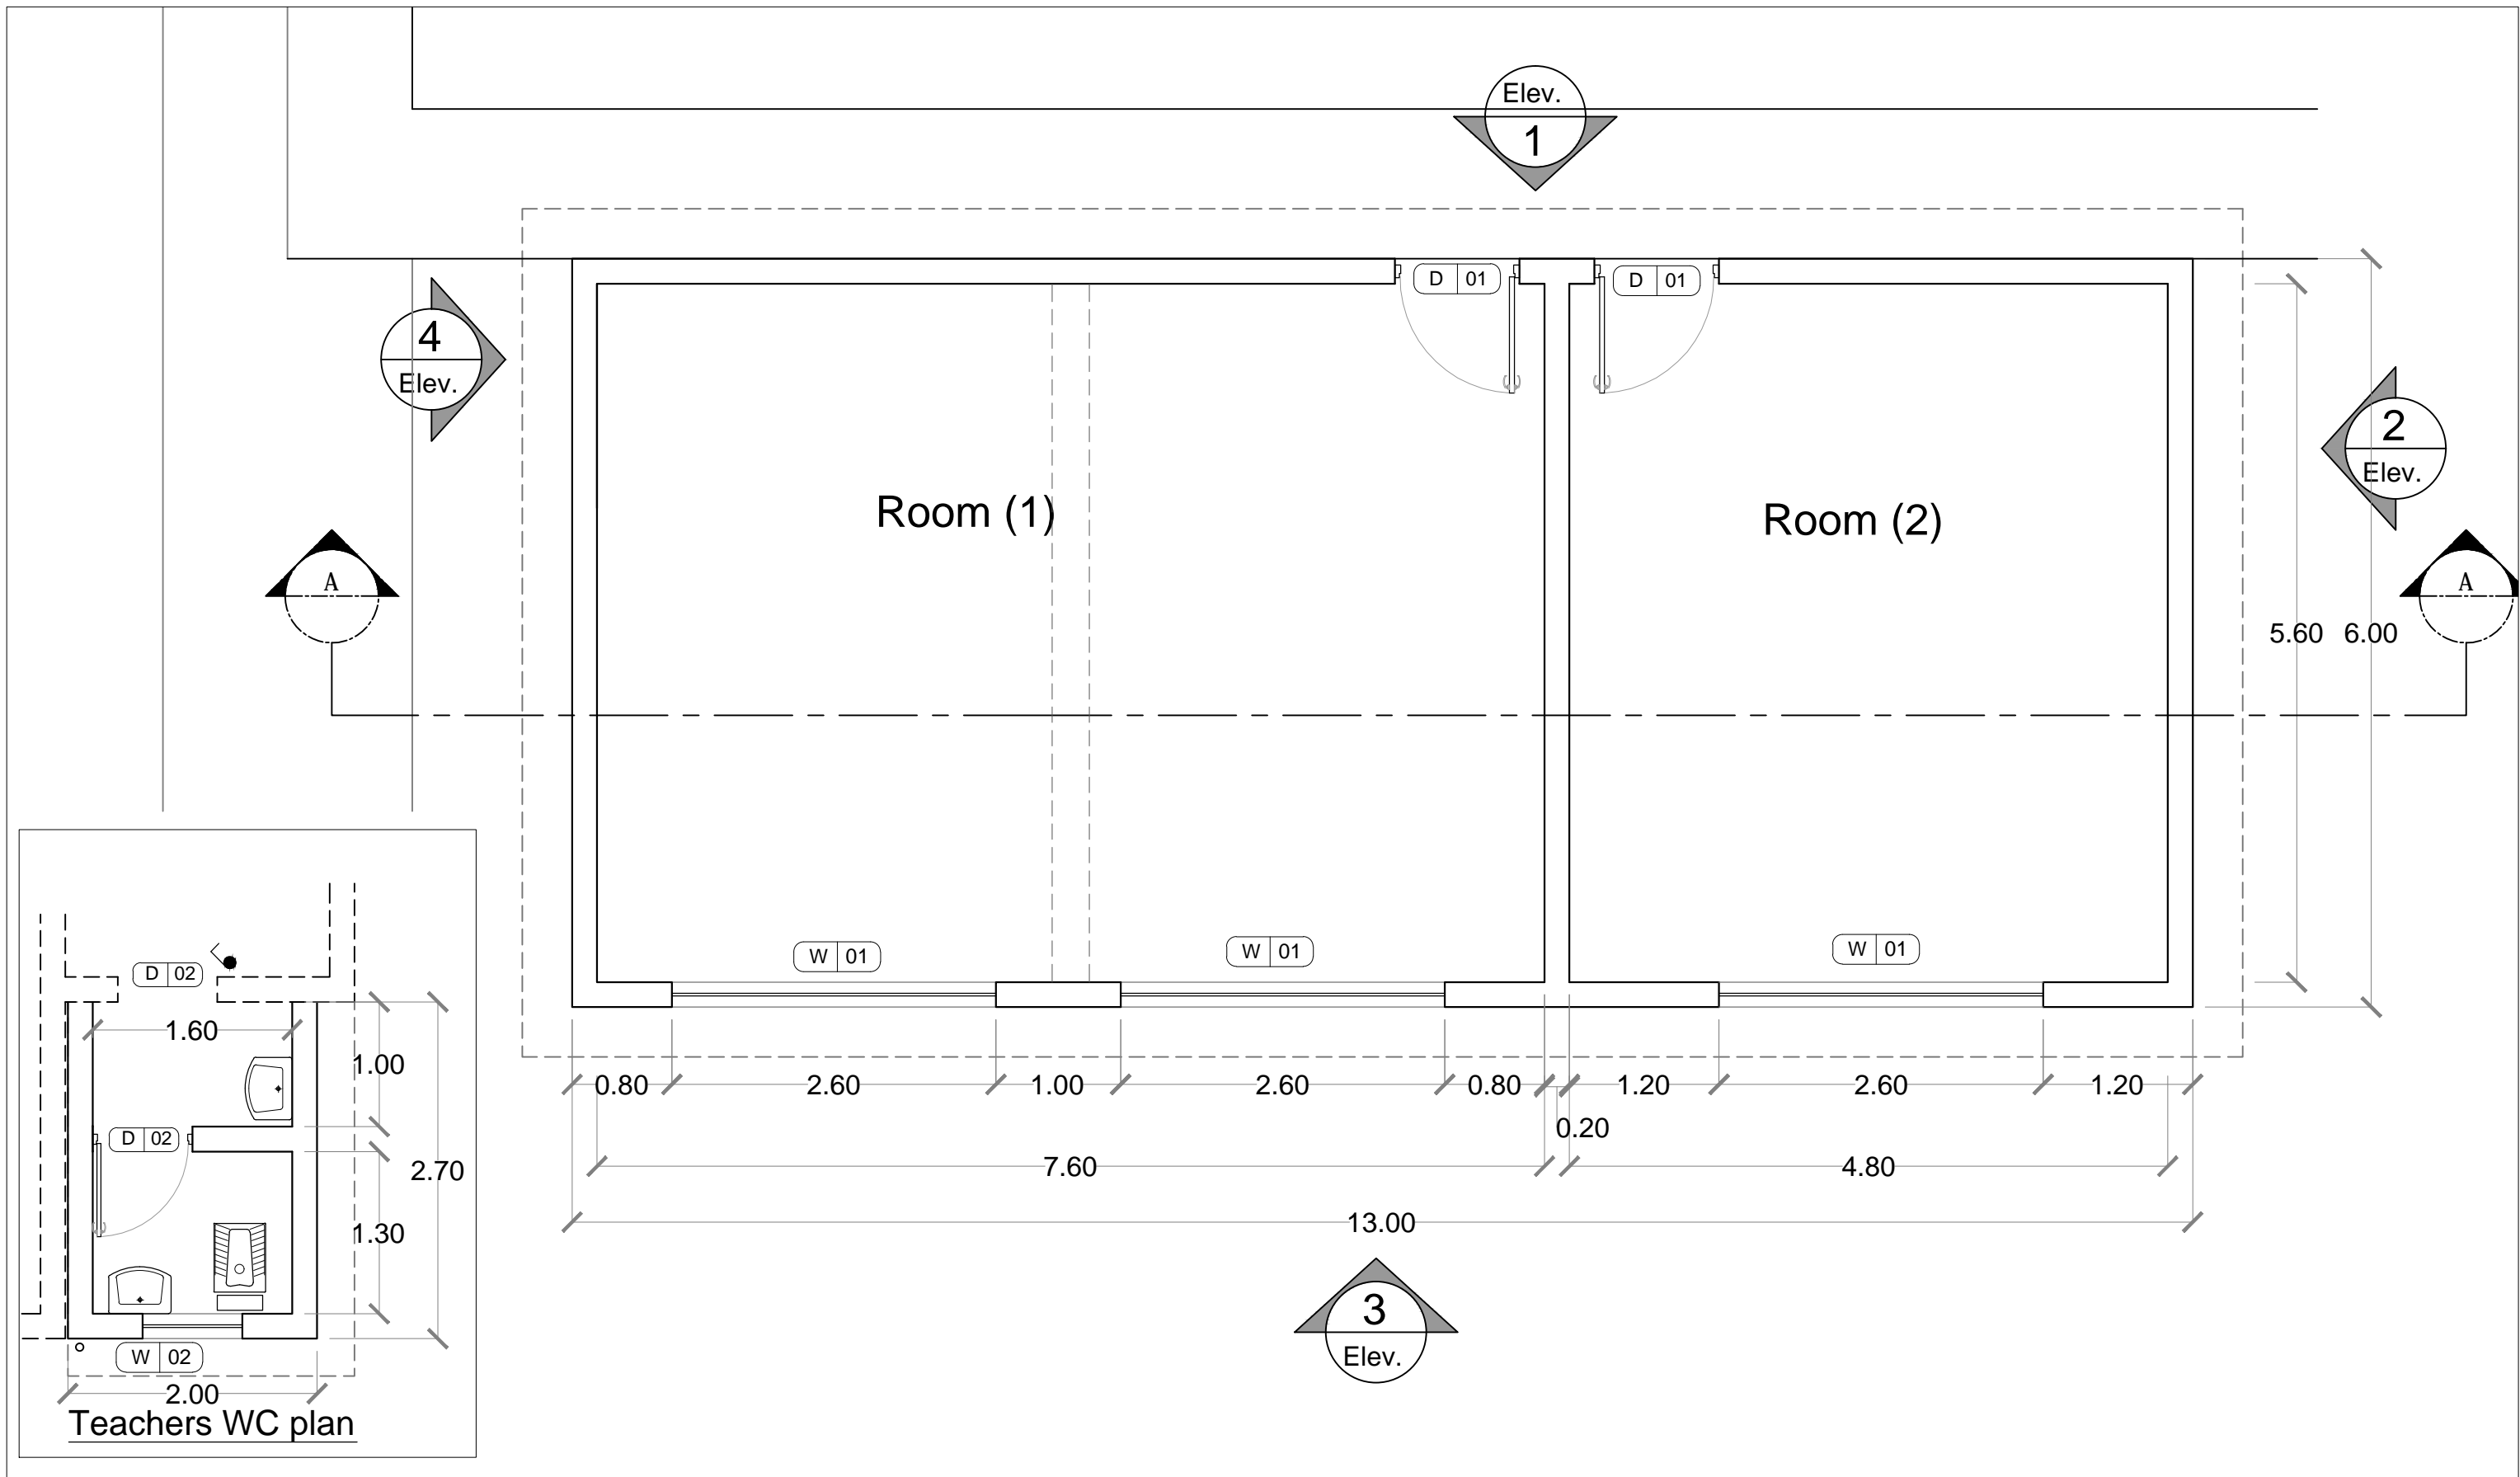


	Name	Signature	Date	Drawing Title	Scale	Sheet NO.
Design Engineer	K. B		Mar. 2017	Site plan Rozhi Nuwe' school		A 01
Design Architect	K. B					
Supervising/QC engineer						
Project Officer						
Government Representative						
Programme Manager						
						Sheet size: A 3



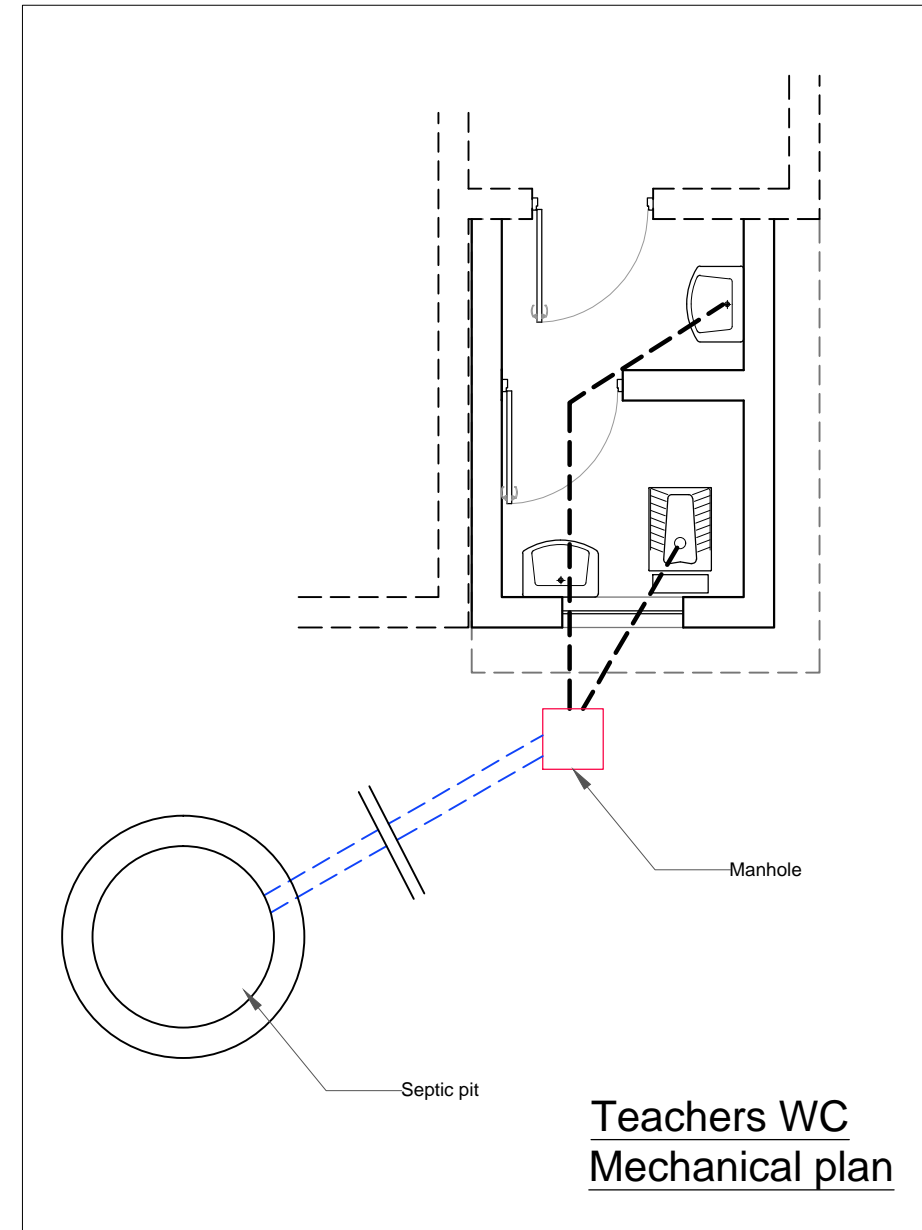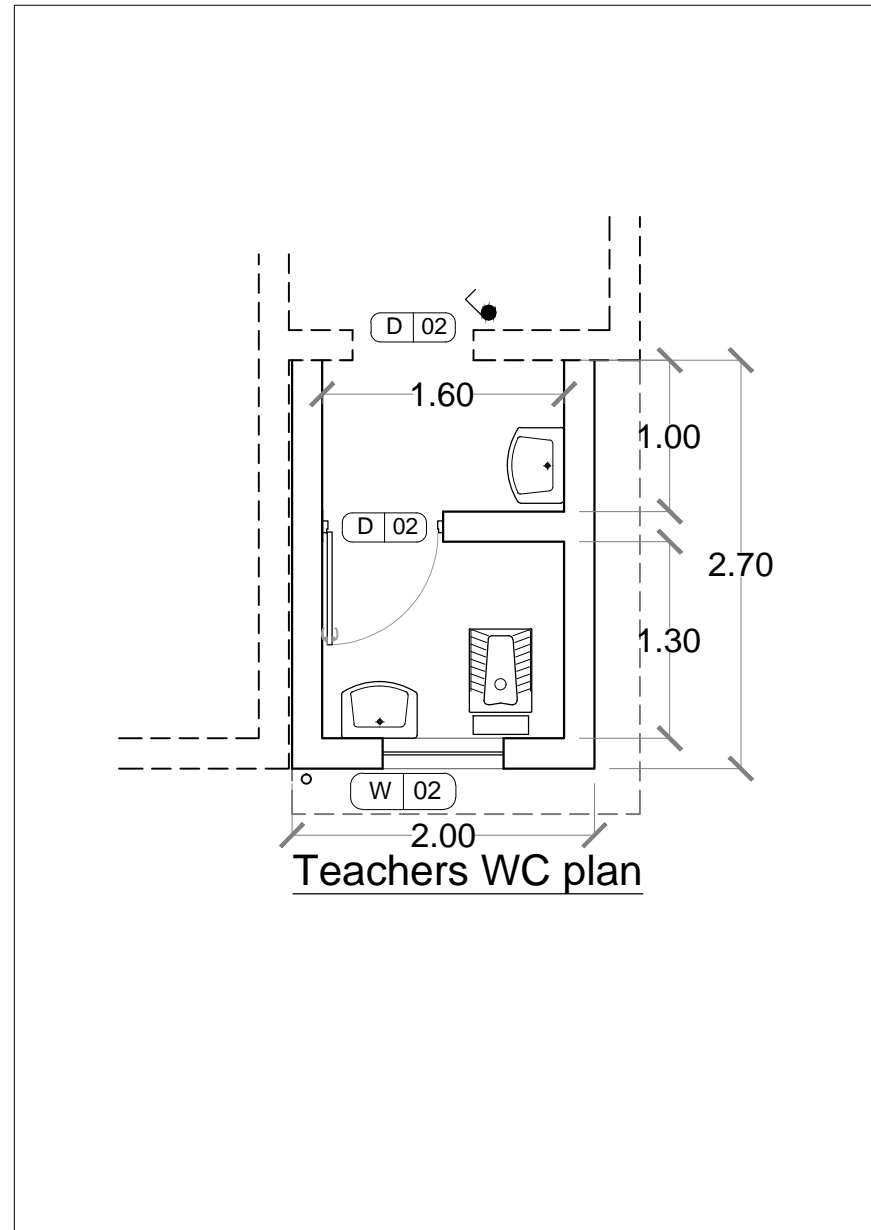



Community Revitalization Programme CRP		Design Engineer	K. B			Date Mar. 2017	Drawing Title Classrooms Plan Teachers WC plan (New construction)	Scale 1 : 50	Sheet NO. A 02
		Design Architect	K. B						
International Organization for Migration - IRAQ		Supervising/QC engineer							
		Project Officer							
		Government Representative							
		Programme Manager					Rozhi Nuwe' school		Sheet size: A 3

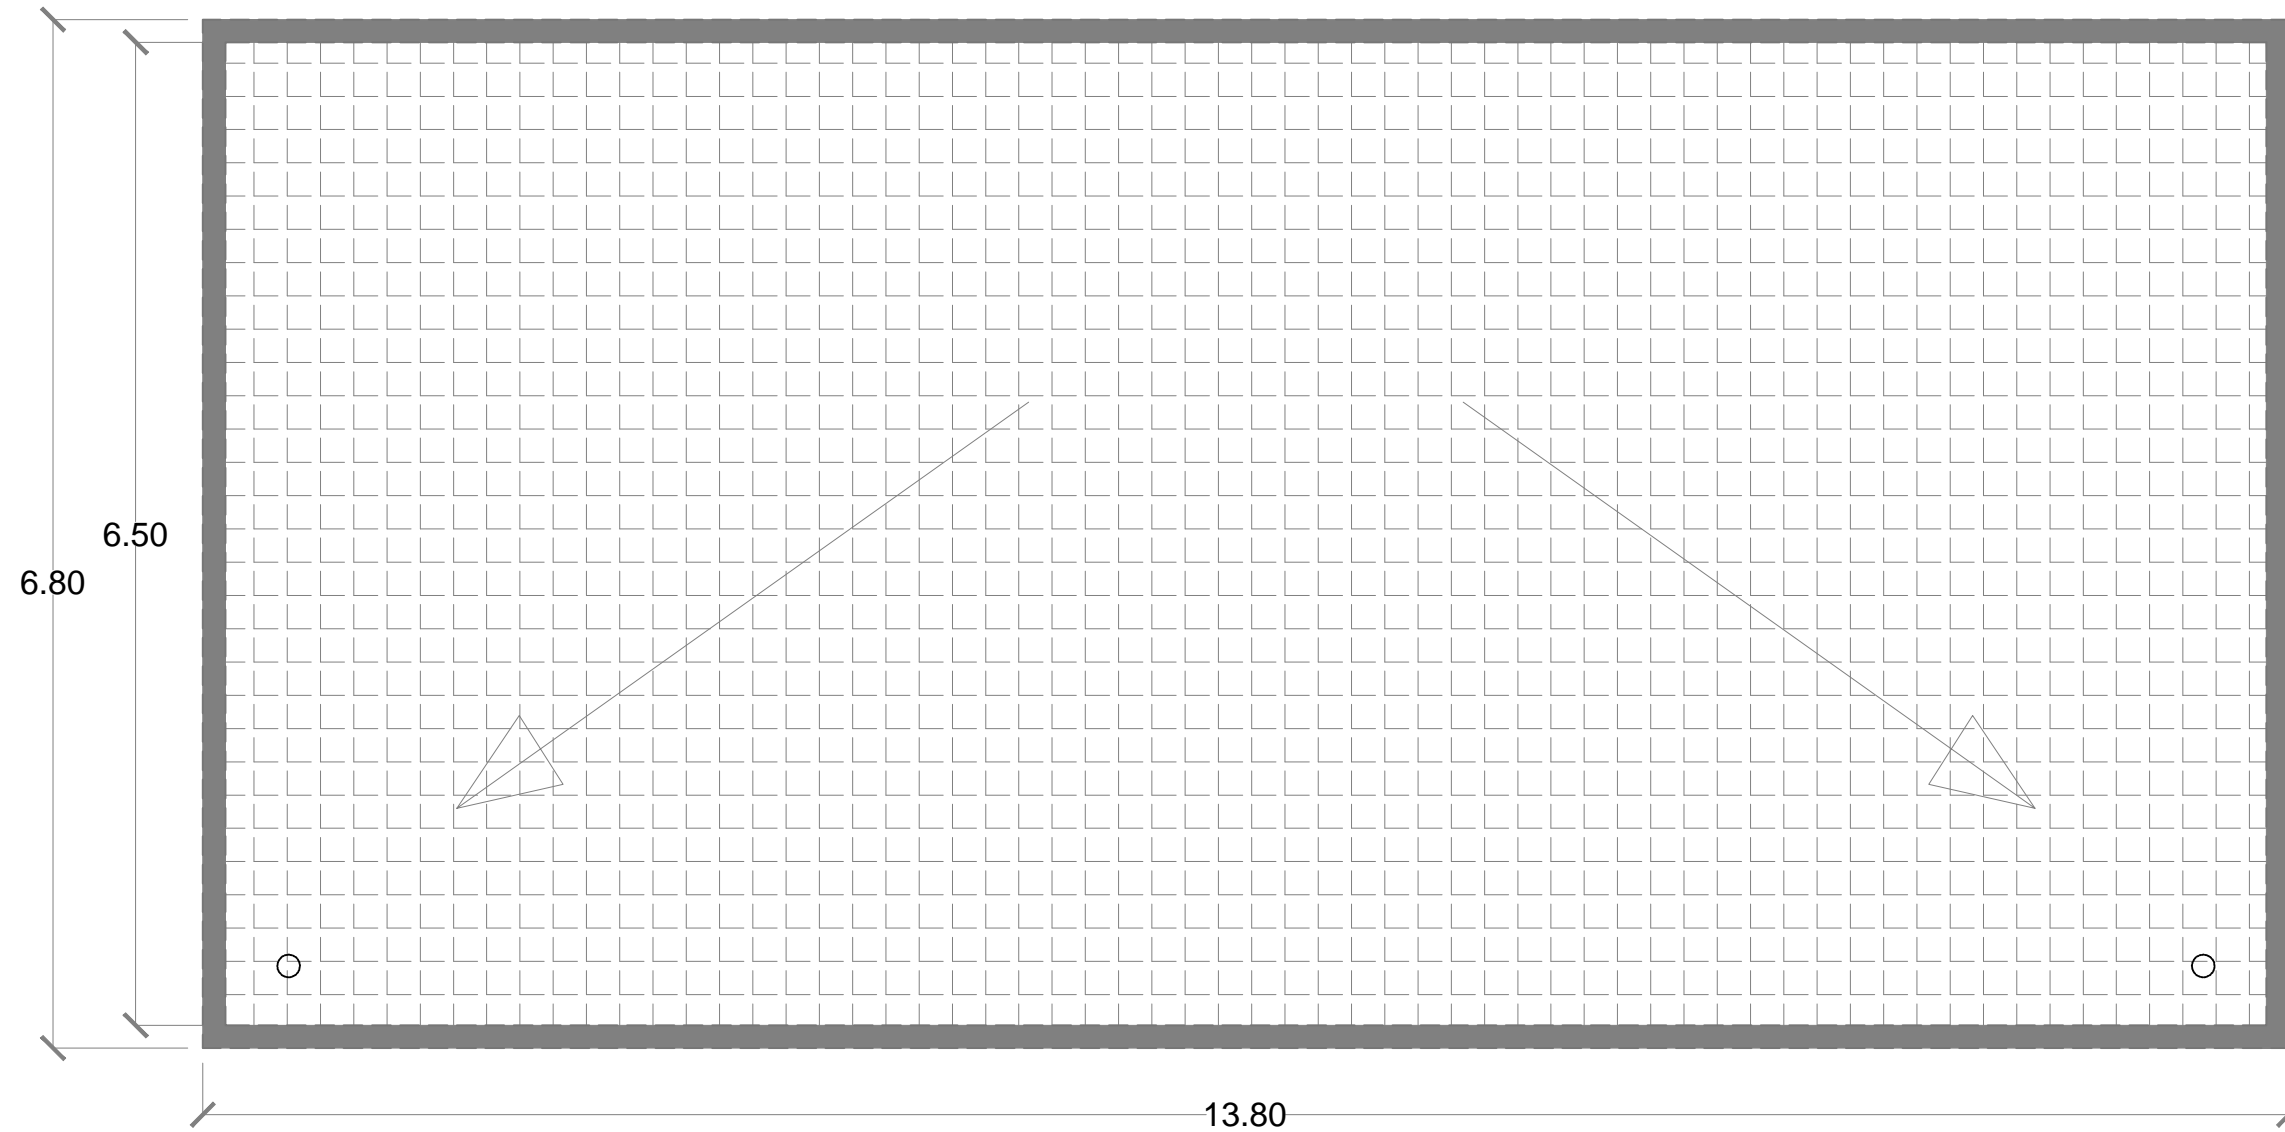

Community Revitalization Programme CRP			Name	Signature	Date	Drawing Title	Scale	Sheet NO.
		Design Engineer	K. B		Mar. 2017			
International Organization for Migration - IRAQ		Design Architect	K. B			Teachers WC plan & Mechanical works (New construction)	1 : 50	A 03
		Supervising/QC engineer						
		Project Officer						
		Government Representative						
		Programme Manager				Rozhi Nuwe' school		Sheet size: A 3



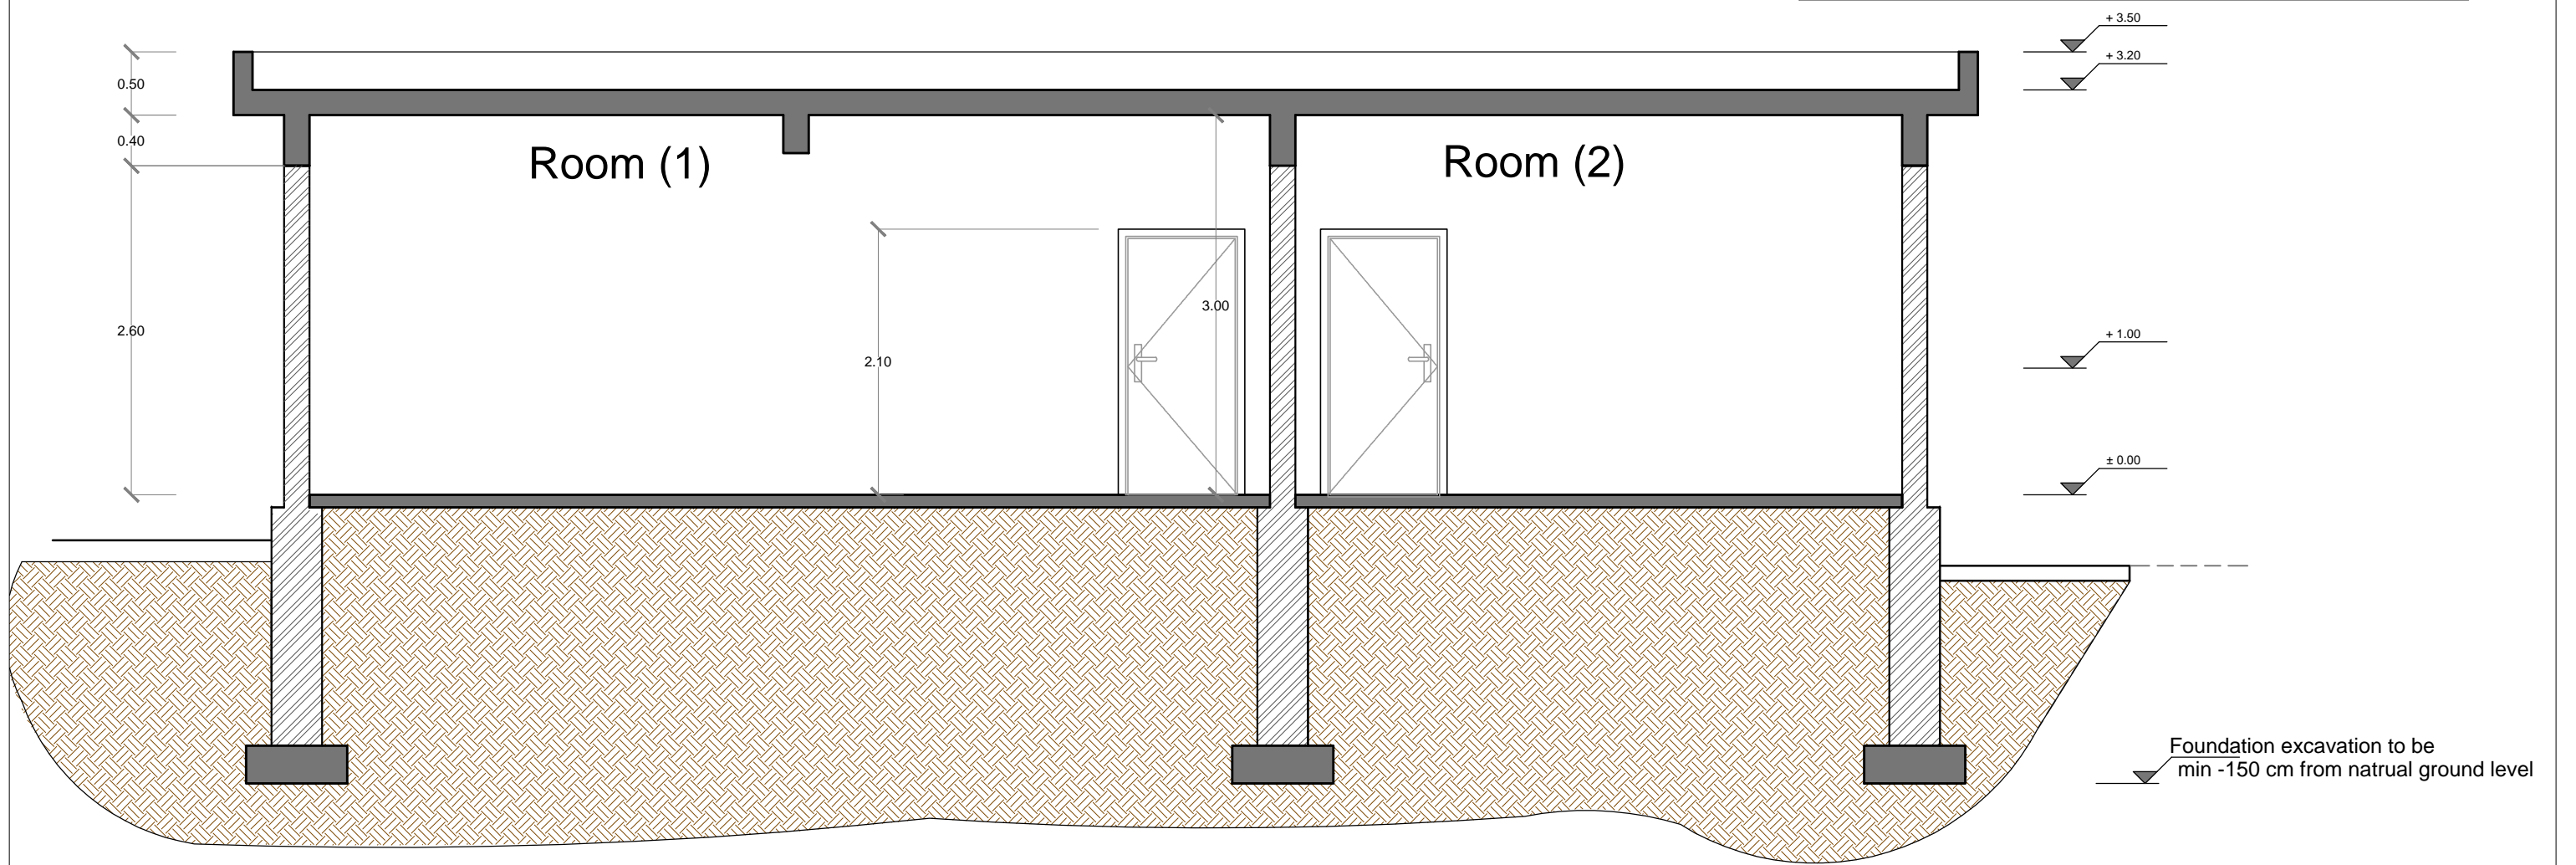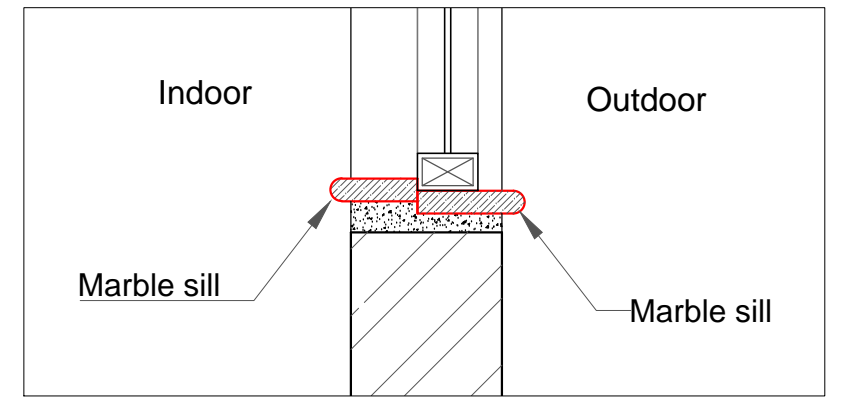

Community Revitalization Programme CRP		Design Engineer					Drawing Title	Scale	Sheet NO.
		Design Architect	K. B			Mar. 2017			
International Organization for Migration - IRAQ		Supervising/QC engineer					Rozhi Nuwe' school		Sheet size: A 3
		Project Officer							
		Government Representative							
		Programme Manager							




Section AA

scale: 1:50


Community Revitalization Programme CRP		Design Engineer	K. B		Mar. 2017	Drawing Title	Scale	Sheet NO.
		Design Architect	K. B					
International Organization for Migration - IRAQ		Supervising/QC engineer				Section AA	1 : 50	A 05
		Project Officer						
		Government Representative						
		Programme Manager				Rozhi Nuwe' school		Sheet size: A 3

Cement Plastering
with Exterior painting finish

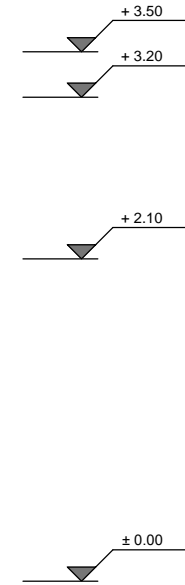

Elevation - 1

Cement Plastering
with Exterior painting finish

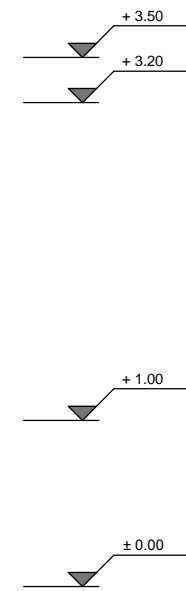

Elevation - 3


Community Revitalization
Programme CRP










International Organization
for Migration - IRAQ

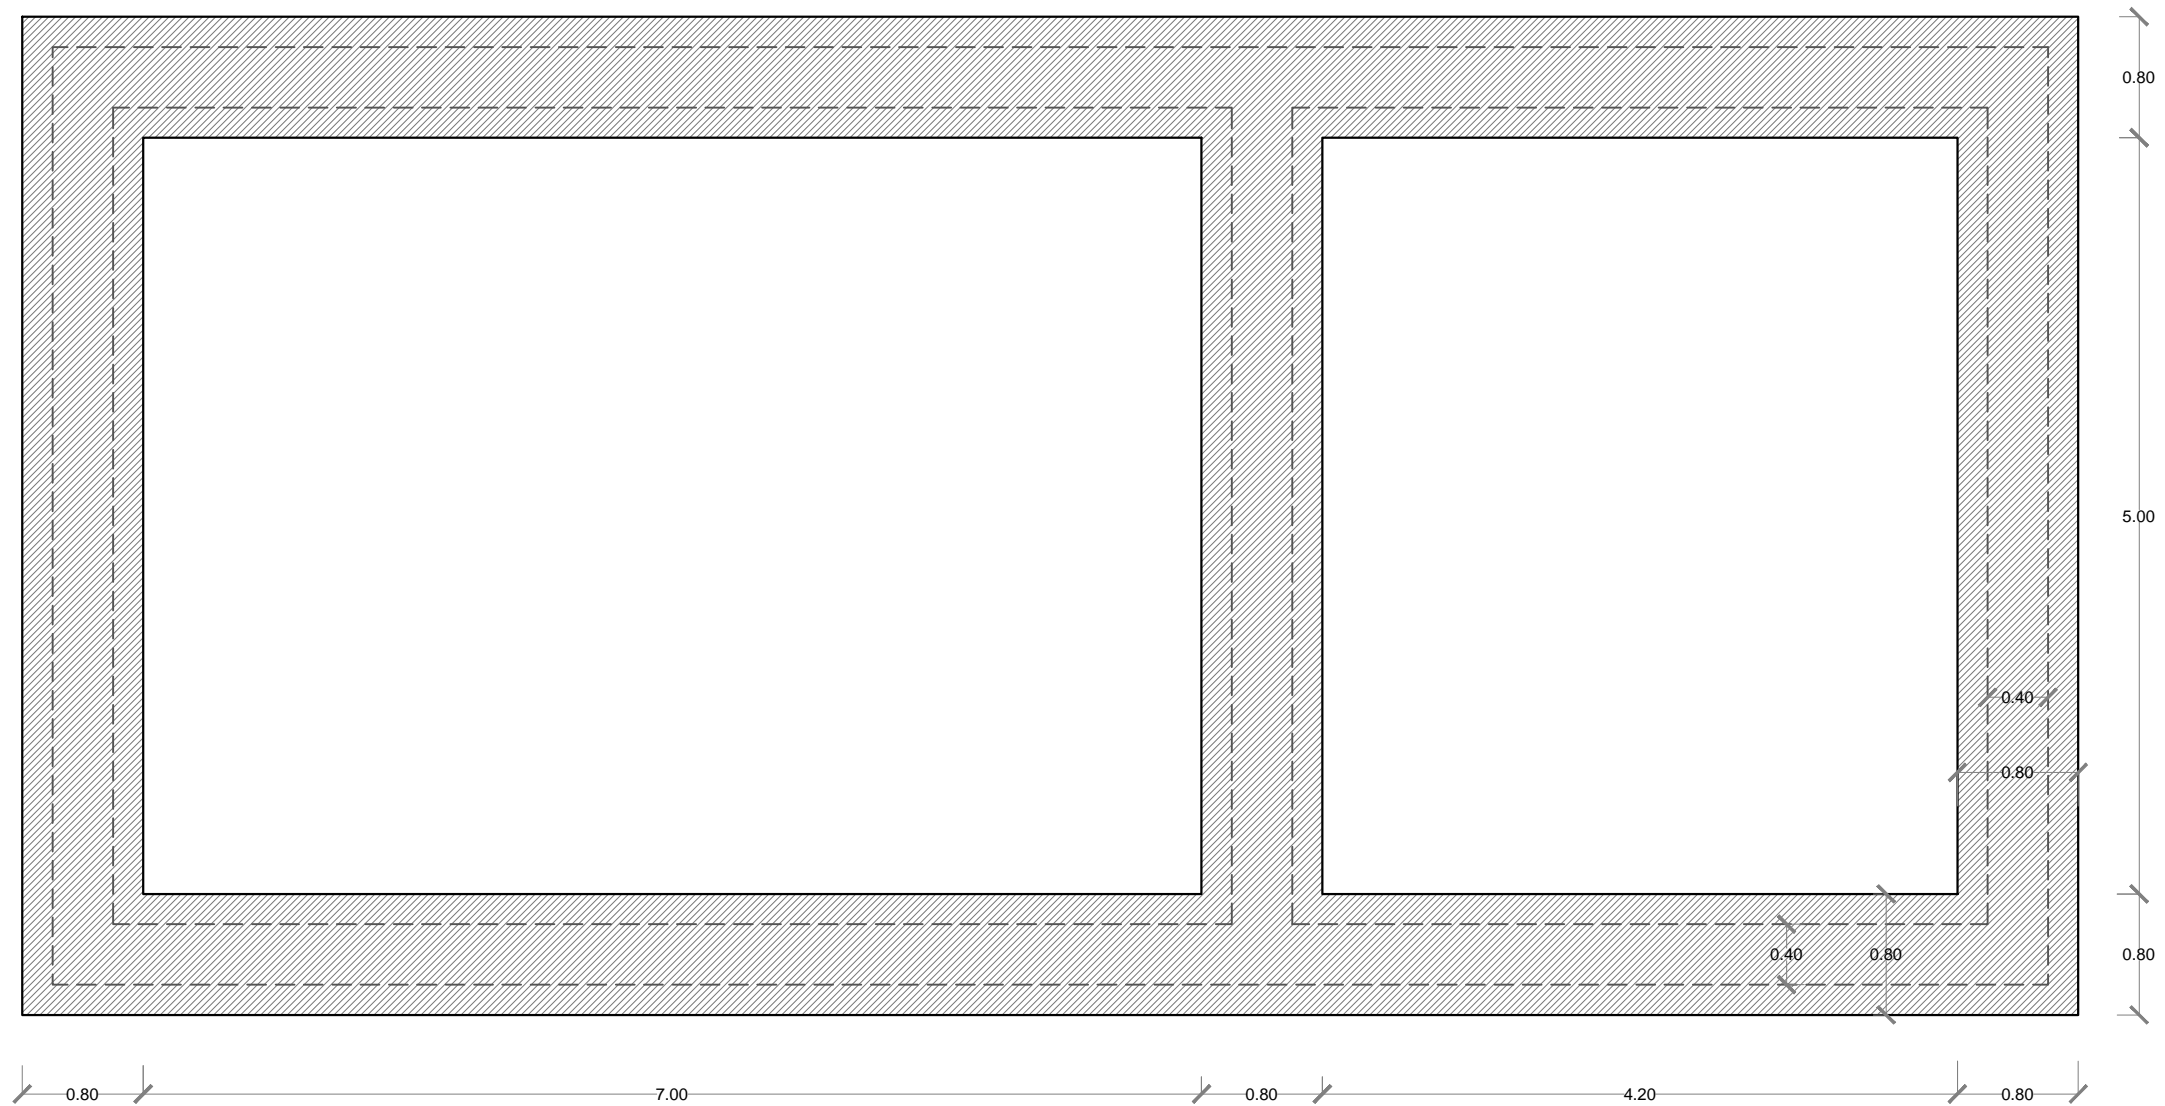



	Name	Signature	Date	Drawing Title	Scale	Sheet NO.
Design Engineer	K. B		Mar. 2017	Elevation 1 & 3 Rozhi Nuwe' school	1 : 50	A 06
Design Architect	K. B					
Supervising/QC engineer						
Project Officer						Sheet size: A 3
Government Representative						
Programme Manager						



 


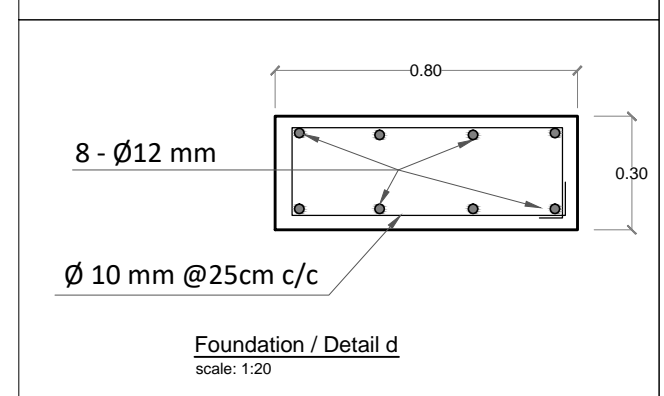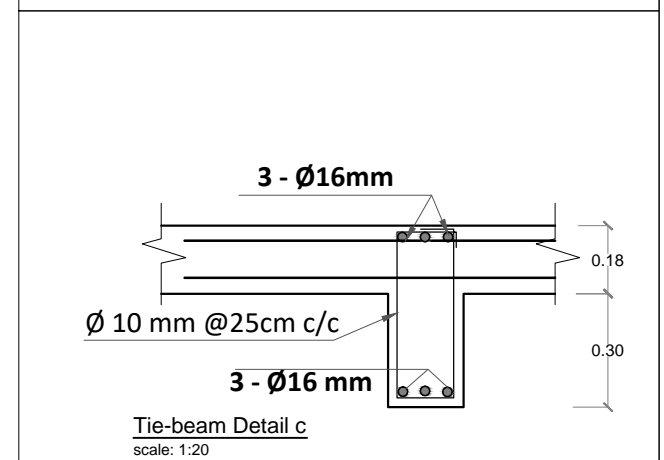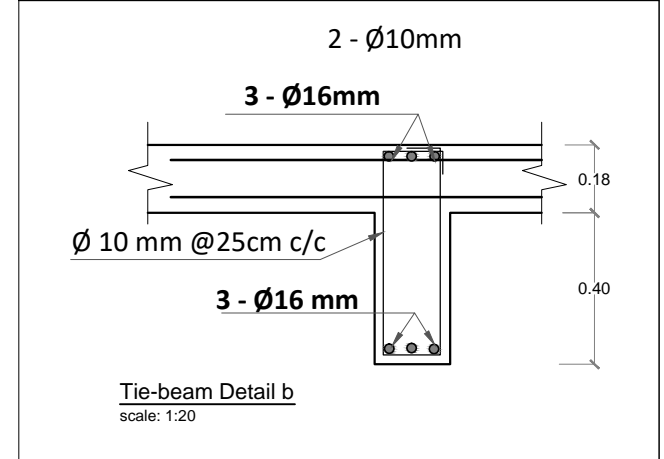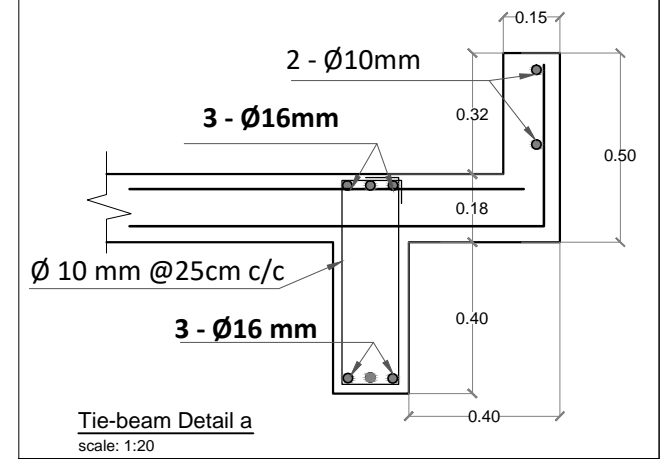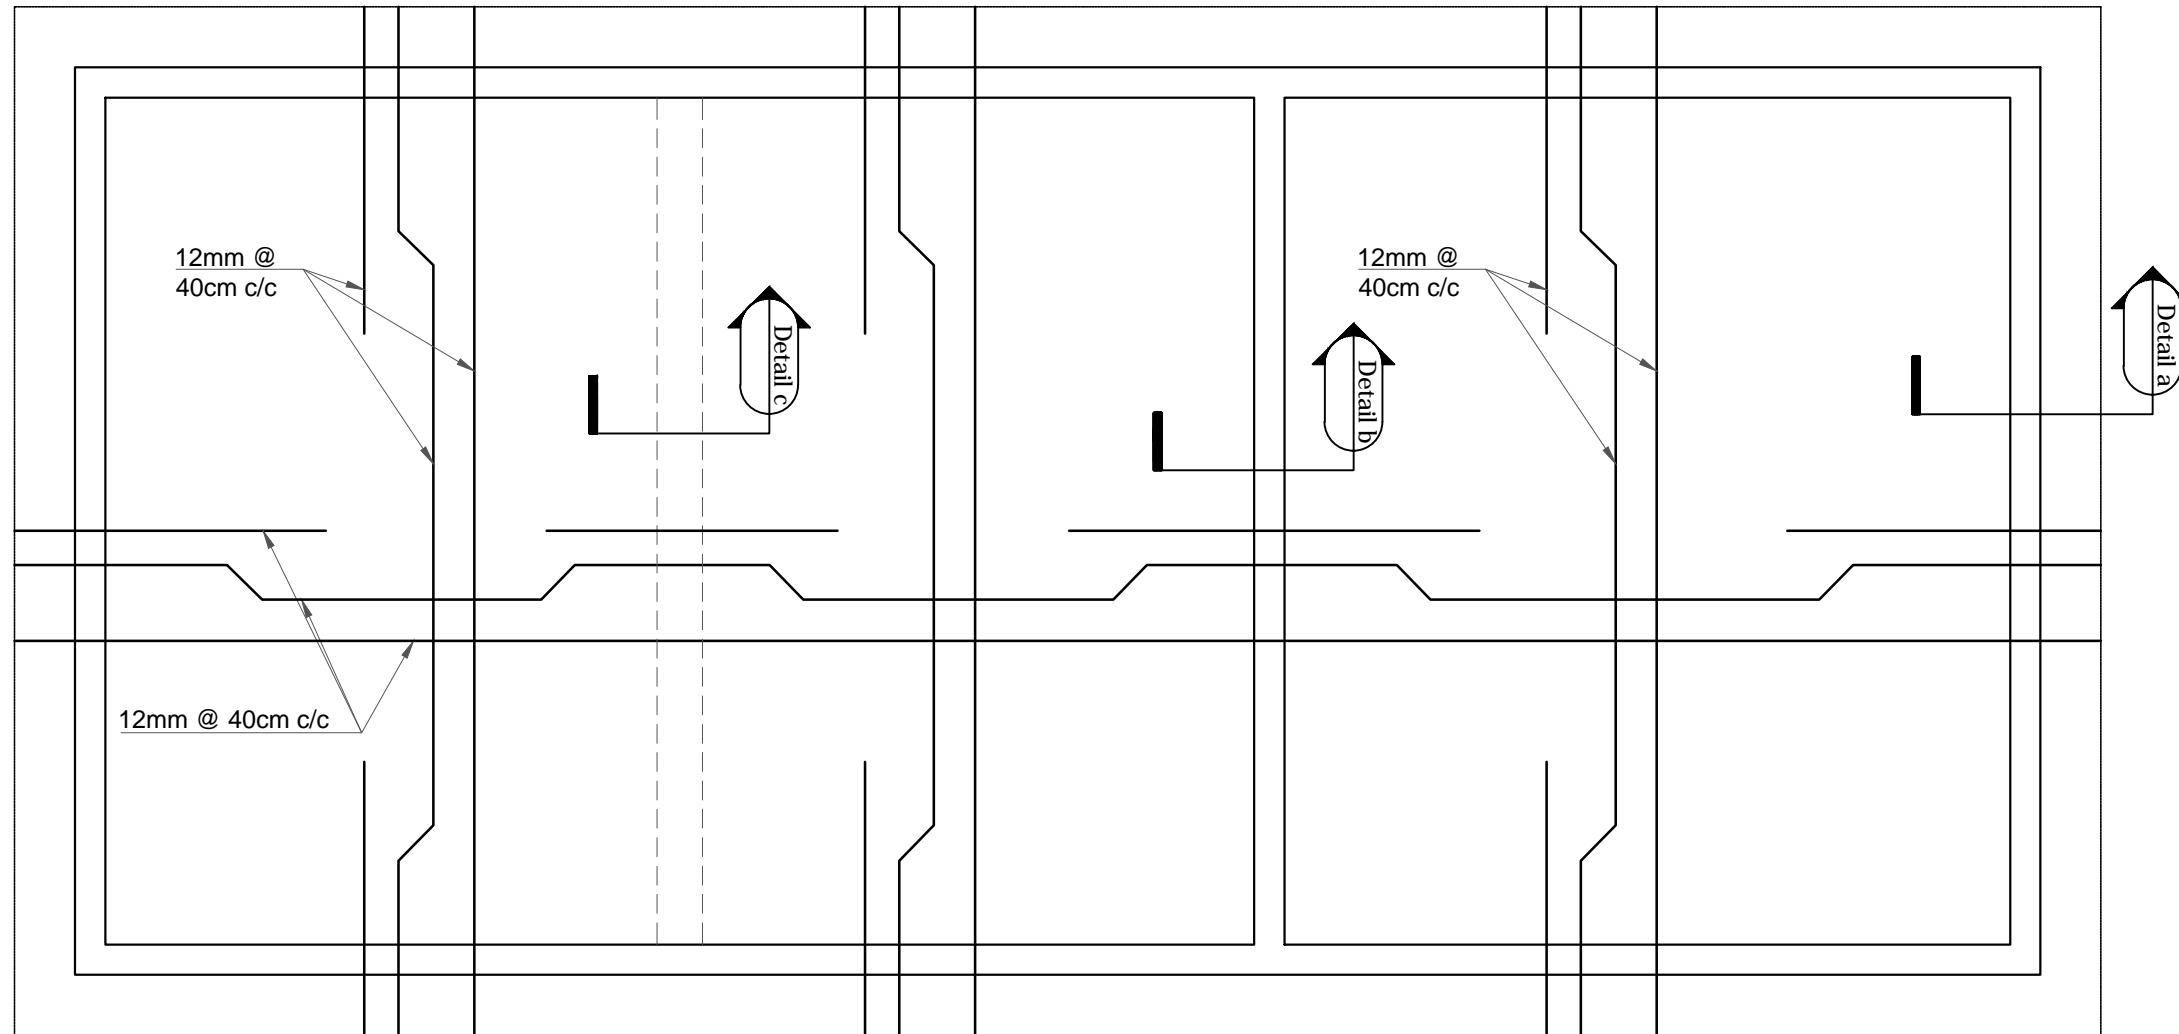


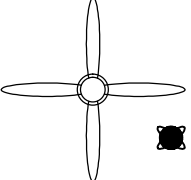


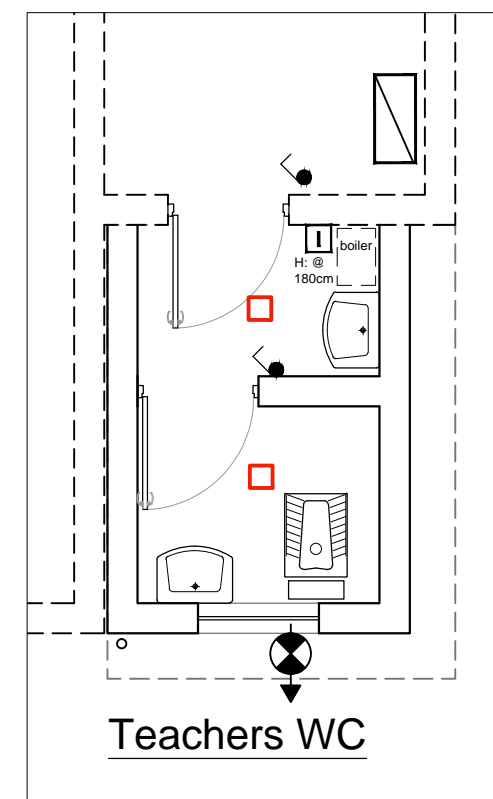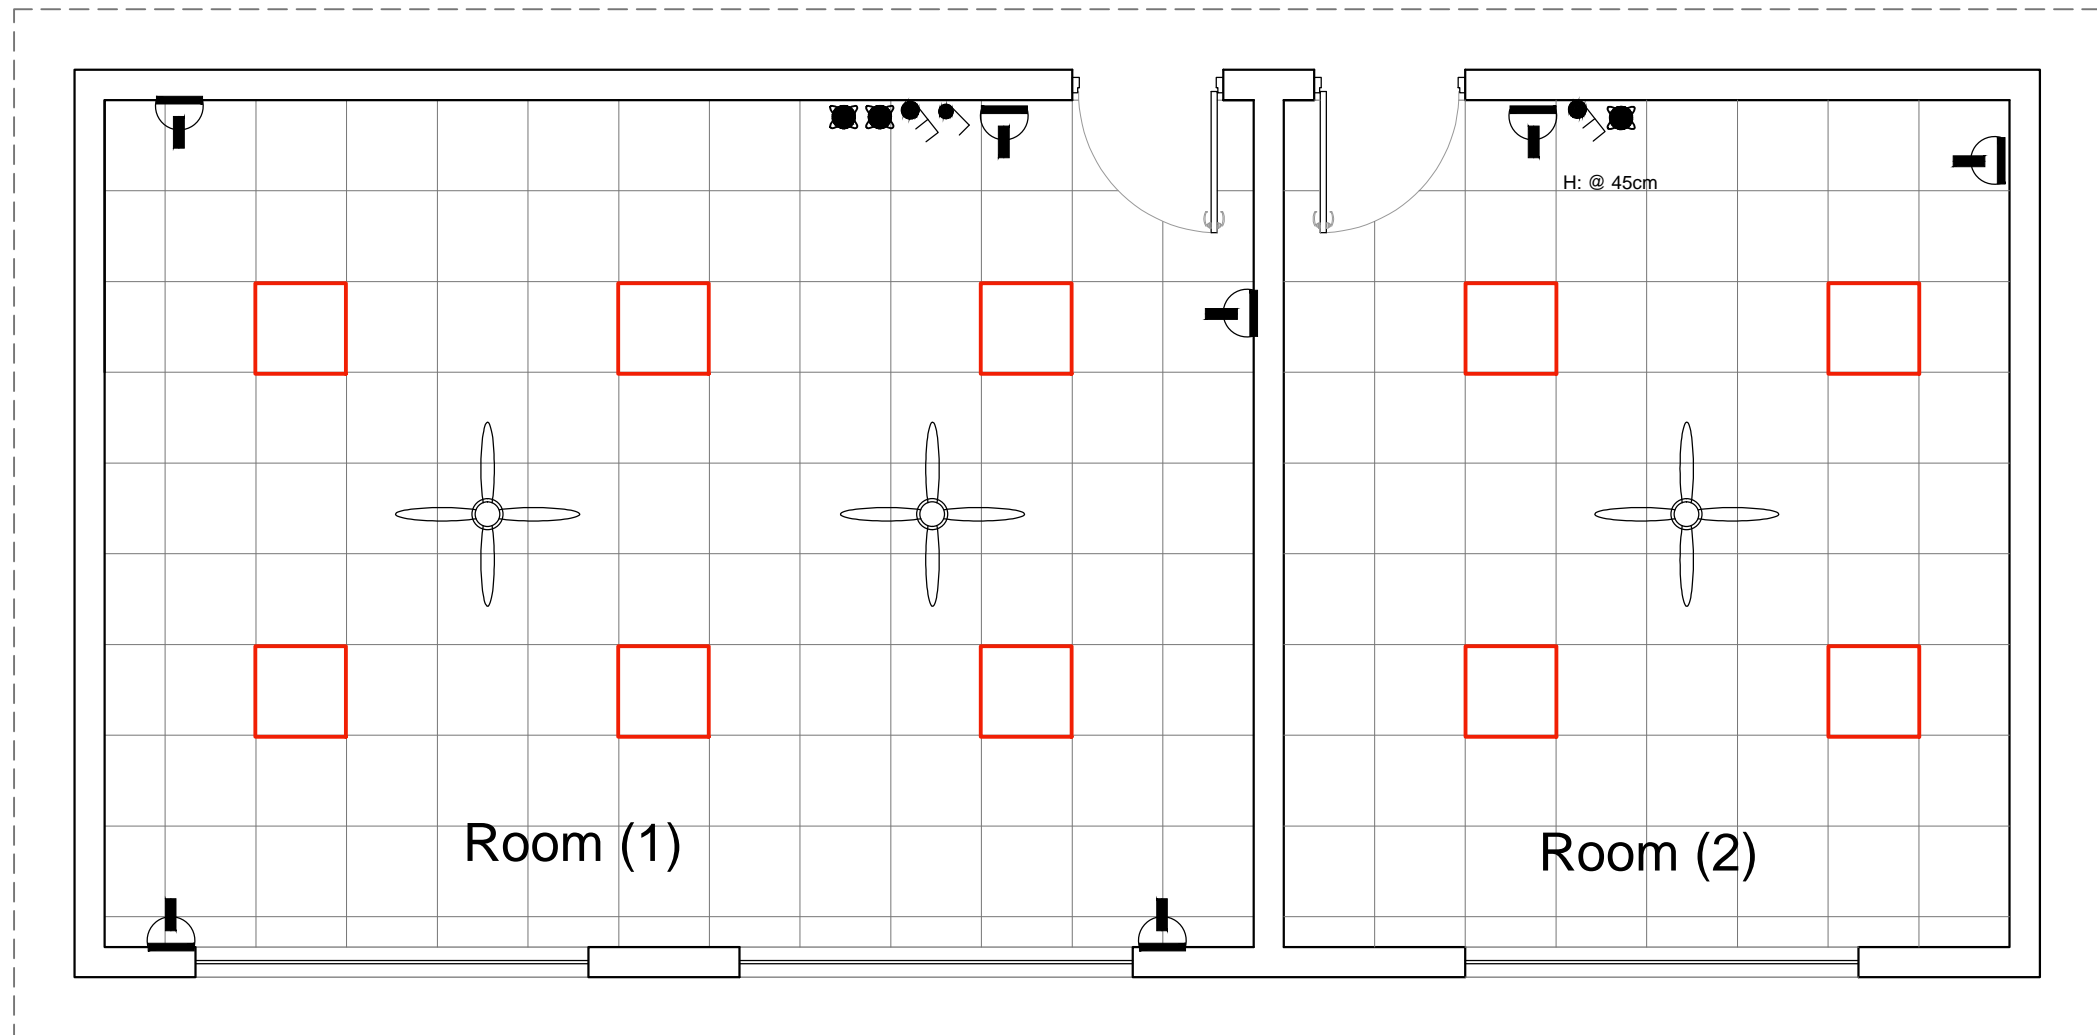

Community Revitalization Programme CRP									
		Design Engineer		K. B		Mar. 2017	Foundation plan		S 01
International Organization for Migration - IRAQ		Design Architect		K. B				Rozhi Nuwe' school	
		Supervising/QC engineer							
		Project Officer							
		Government Representative							
		Programme Manager							







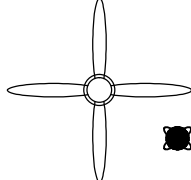
Community Revitalization Programme CRP		Design Engineer	K. B			Mar. 2017	reinforcement Slab plan Details (a, b, c, d)	Scale	Sheet NO.
		Design Architect	K. B						
International Organization for Migration - IRAQ		Supervising/QC engineer					Rozhi Nuwe' school	Sheet size: A 3	
		Project Officer							
		Government Representative							
		Programme Manager							



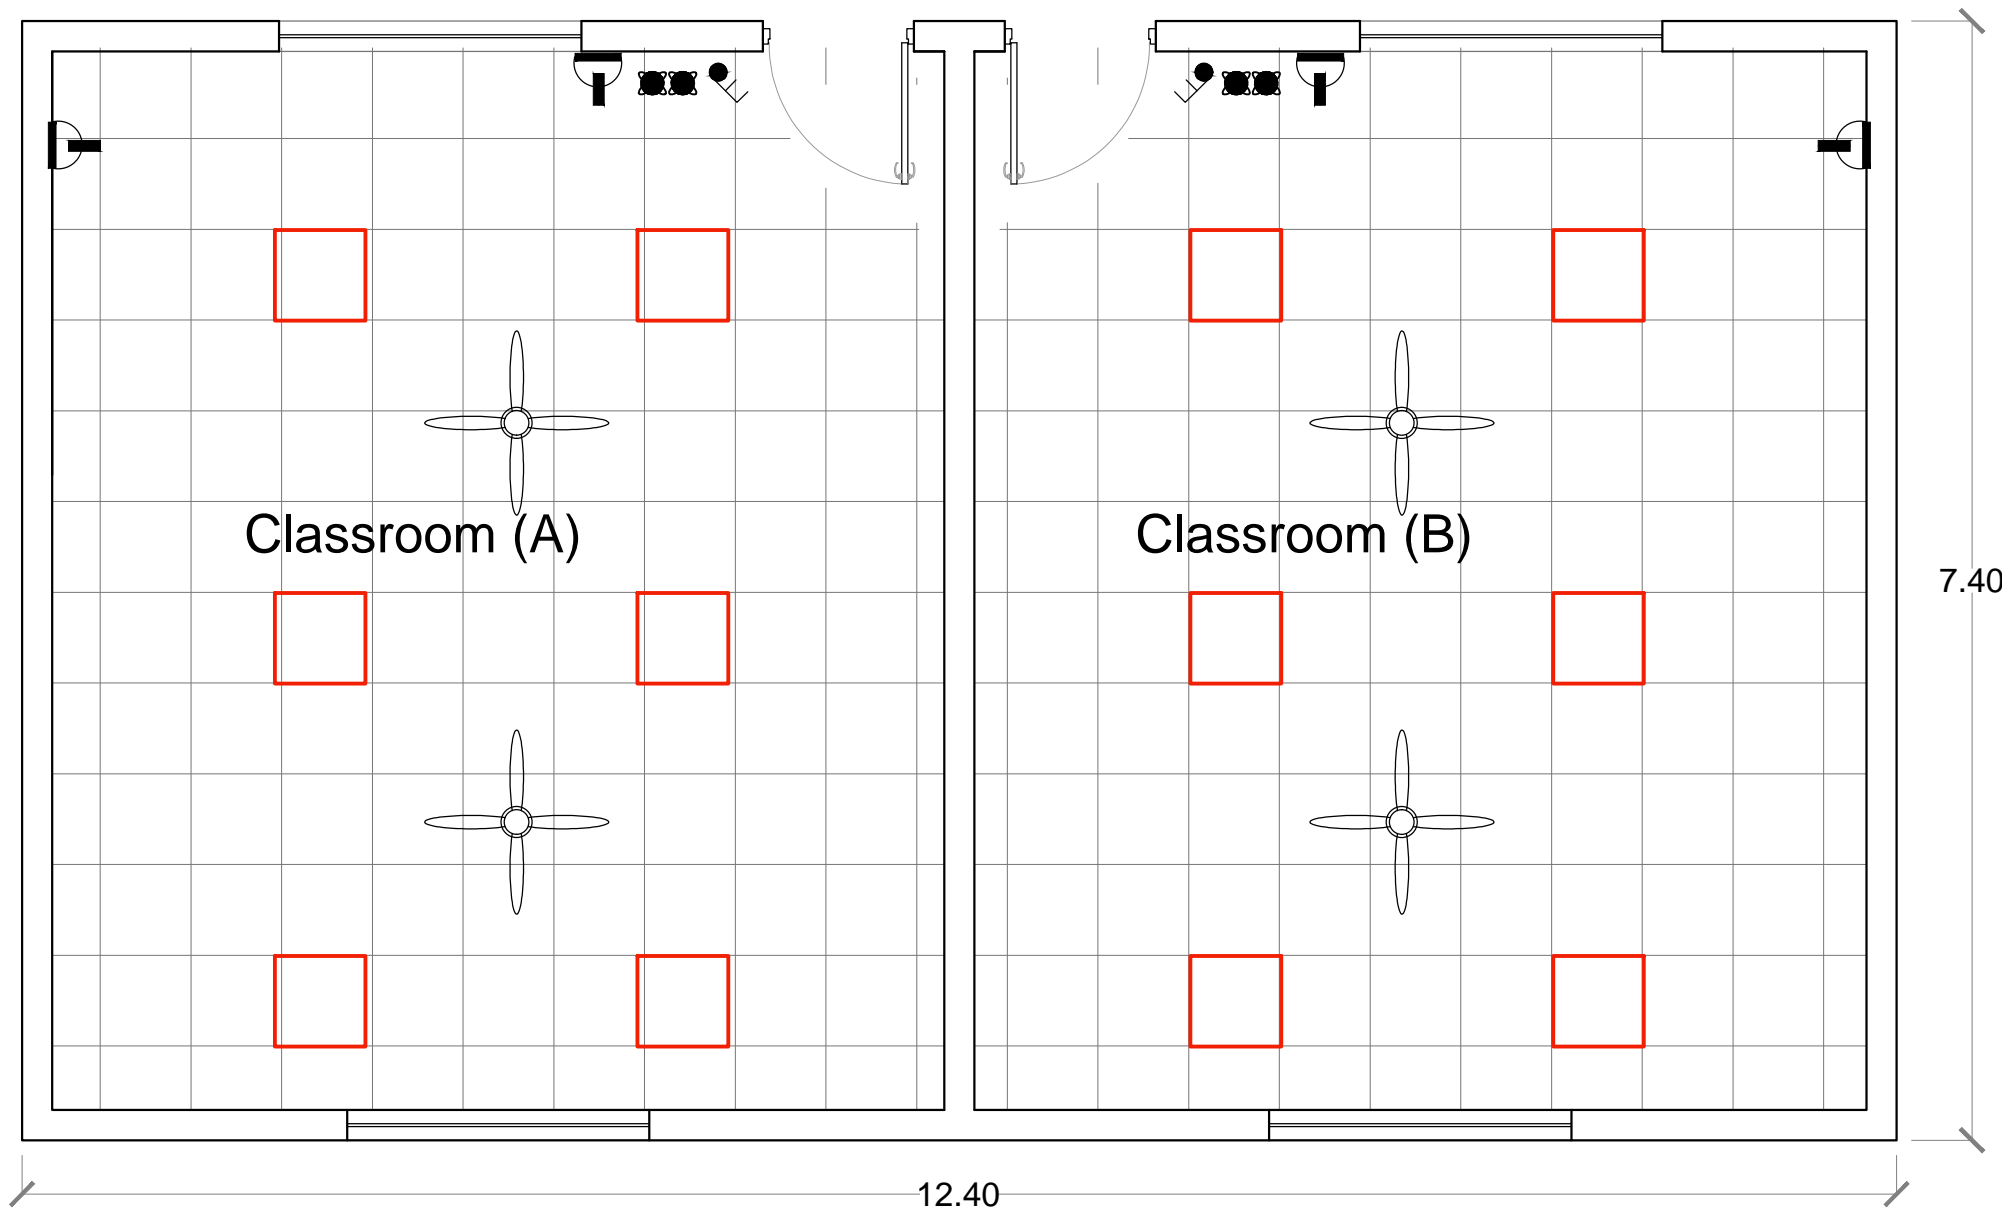

-  30 x 30 LED light
-  60 x 60 LED light
-  Distribution Board
-  Switch Single
-  Switch Double
-  Power Switch Socket (13 Amp)
-  Grid Switch (20 - 32 Amp)
-  Exhaust fan
-  Ceiling mounted fan with dimmer on/off switch

Community Revitalization Programme CRP 	Design Engineer	K. B			Mar. 2017	Electrical plan	Scale	Sheet NO. E 01
	Design Architect	K. B						
International Organization for Migration - IRAQ 	Supervising/QC engineer					Rozhi Nuwe' school		Sheet size: A 3
	Project Officer							
	Government Representative							
	Programme Manager							



-  60 x 60 LED light
-  Switch Double
-  Power Switch Socket (13 Amp)
-  Ceiling mounted fan with dimmer on/off switch

Community Revitalization Programme CRP 	Design Engineer	K. B			Mar. 2017	Classrooms plan	Scale	Sheet NO. A 08
	Design Architect	K. B						
International Organization for Migration - IRAQ 	Supervising/QC engineer					Dari Zard school		Sheet size: A 3
	Project Officer							
	Government Representative							
	Programme Manager							